

AIR CONDITIONING WORK

LEGEND


S.NO.	DESCRIPTION	SYMBOL	
01.	MULTI SPLIT UNIT /INDOOR UNIT		+7'6"
02.	OUTDOOR UNIT		PREFERABLE AT TERRACE / AT SPECIFIED POSITION
03.	DRAIN PIPE		AS PER SITE
04.	COPPER PIPE		AS PER SITE
05.	POWER SUPPLY TO AC FROM AC DB THROUGH METEL CLAD BOX		AS PER SITE

NOTE—

1. POSITION OF CASSETTE UNITS AS PER REFLECTED CEILING PLAN.

2. NO OUTDOOR UNIT SHALL BE INSTALLED AT OR NEAR MAIN ENTRY OF B.O., PUBLIC CORRIDOR, PASSAGES & PEDESTRIAN PATHS.

3. POSITION OF INDOOR & OUT DOOR UNITS CAN BE ADJUSTED AS PER SITE CONDITIONS.

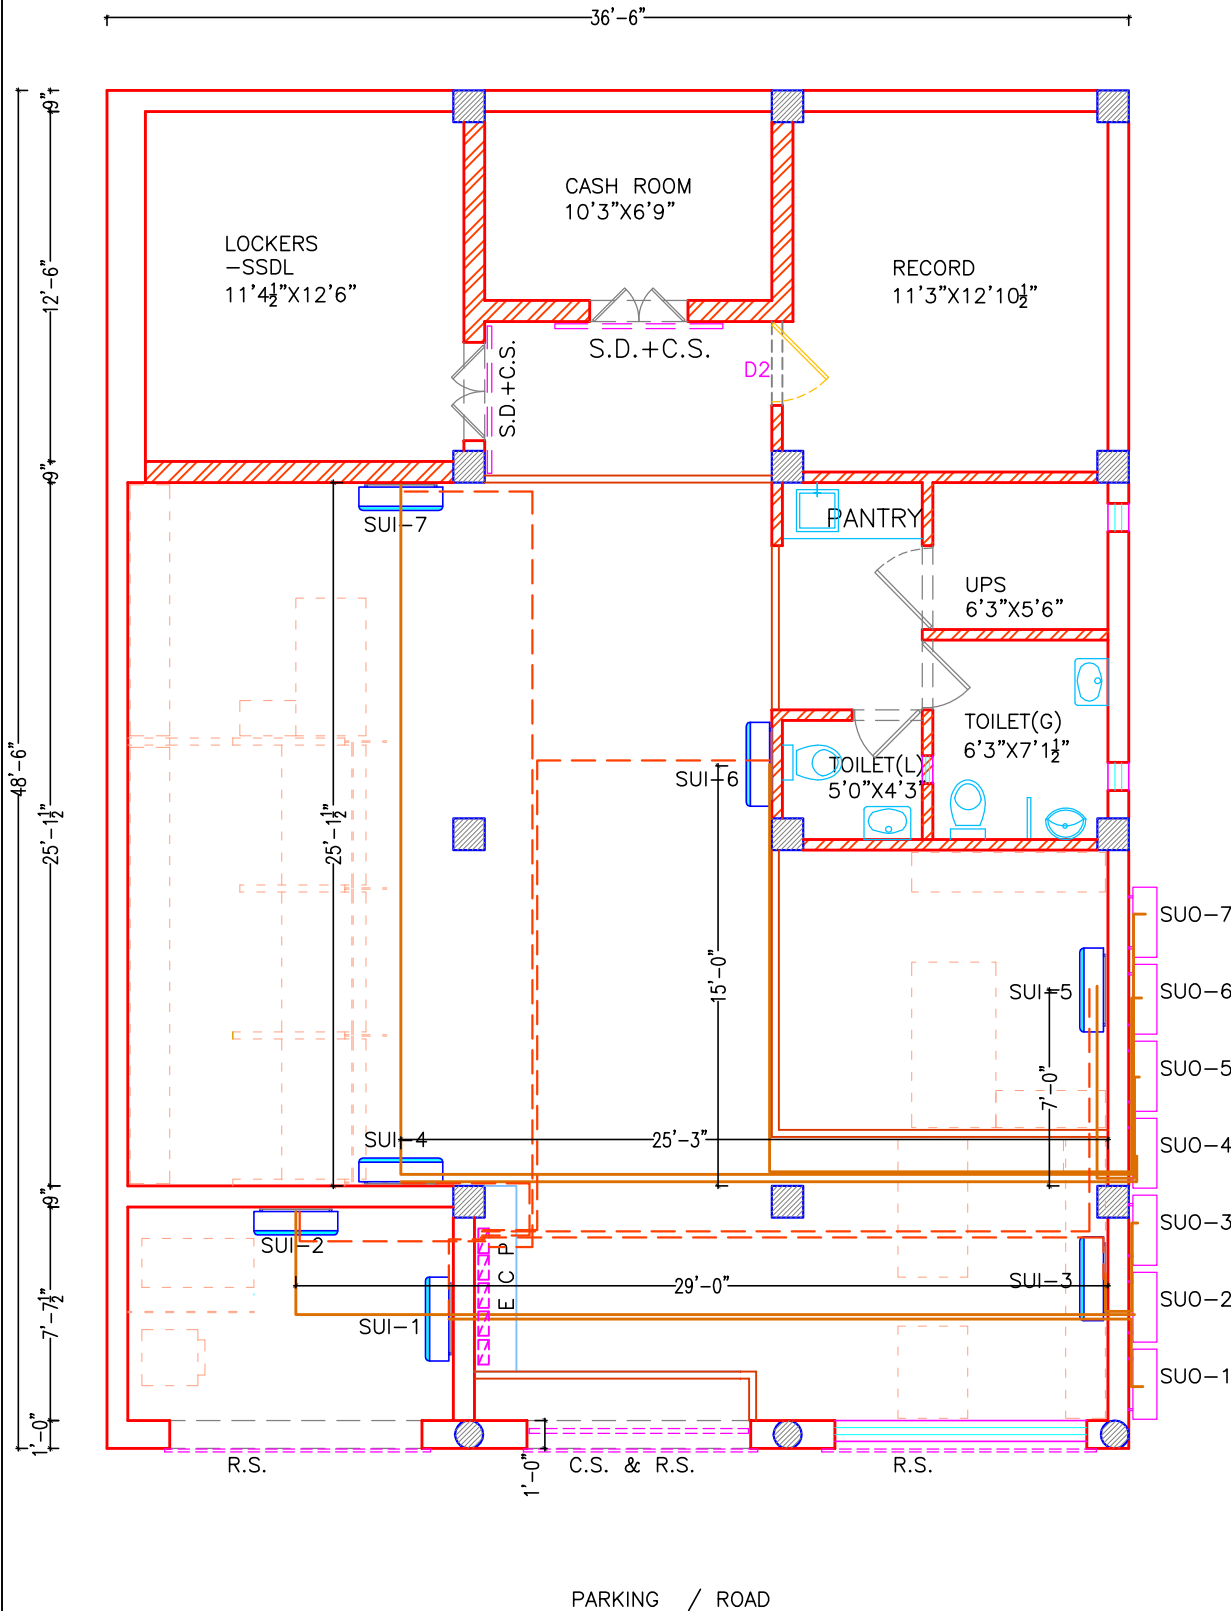

REV.	DESCRIPTION	DATE
TITLE;	LAYOUT PLAN - A.C.	
SCALE	NTS	
DATE	22/01/2025	
JOB NO.	SBI-KH/01	
DRG. NO.	WD-04	
CREATIVE CONCEPTS		
ARCHITECTS,PLANNERS,INT.DESIGNERS		
BOOTH NO. - 32, SECTOR - 25		
PANCHKULA- 134116.		
PH. 09815788192 (M)		

LAYOUT PLAN - G.F.