


**HVAC TENDER DRAWING
OF EXTERNAL AND INTERNAL RENOVATION
ARCHITECT NARAYAN & ASSOCIATES PVT.LTD
OF LHO BUILDING,BHUBANESWAR - ODISHA**

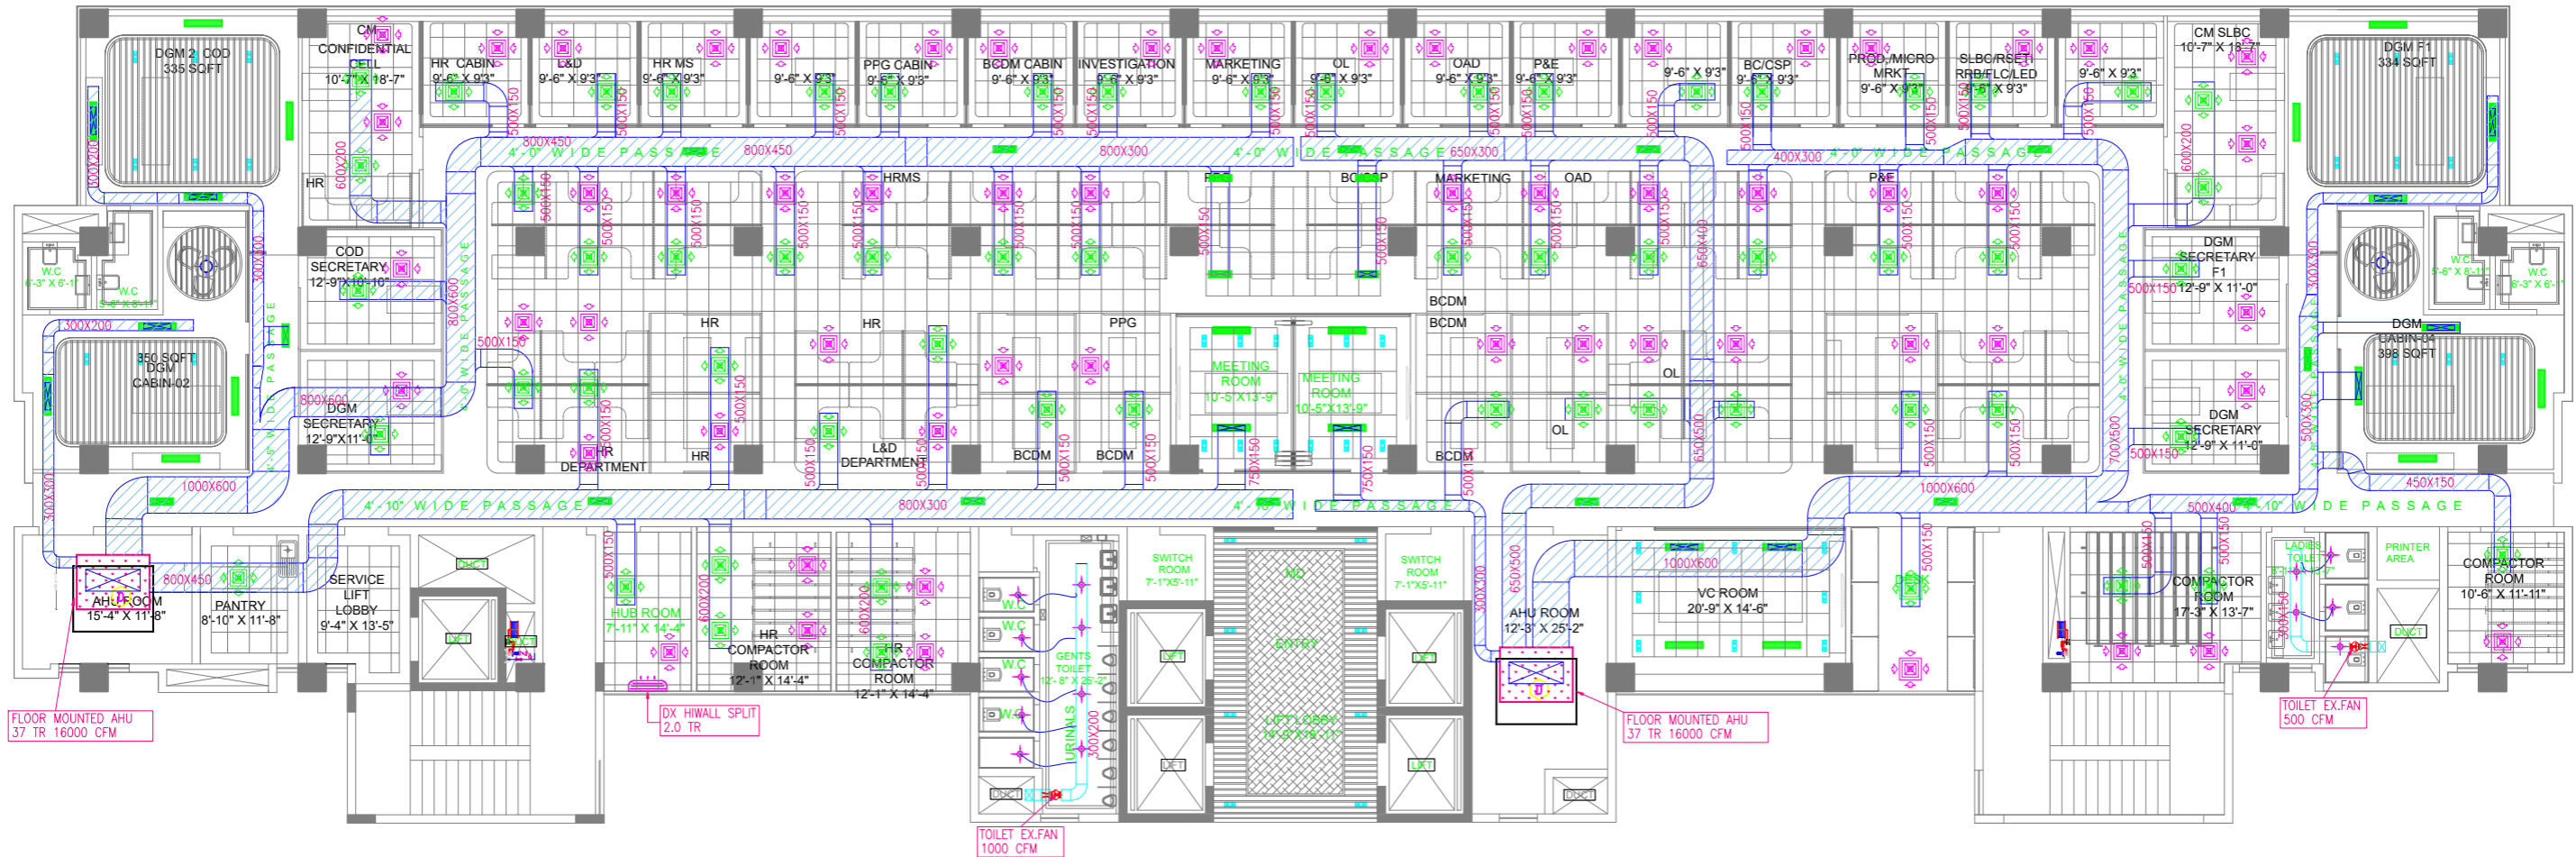


SECOND FLOOR HVAC LAYOUT

HVAC LEGEND		
SL.NO.	SYMBOL	DESCRIPTION
1		RETURN AIR DUCT WITH 19 MM THK THERMAL INSULATION
2		EXHAUST DUCT
3		SUPPLY AIR DIFFUSER
4		RETURN AIR DIFFUSER

HVAC LEGEND		
SL.NO.	SYMBOL	DESCRIPTION
5		SUPPLY & RETURN AIR GRILL
6		DISC VALVE
7		FLEXIBLE DUCT
8		HI-WALL UNIT

DATE:	16.08.2024	05	NOTE :	SR.NO.	DATE :	REMARK/COMMENTS	CLIENT:	DRAWN BY:	CHECKED BY:	Architect Narayan & Associates Pvt. Ltd. MUMBAI OFFICE, 303/304 3rd FLOOR, ANTARISKSH BUILDING MAKWANA ROAD, OFF ANDHERI KURLA RD. MAROL, ANDHERI EAST MUMBAI 400 059 Tel : 91 7208001052 , 91 7208001053 E-mail - info@architectnarayan.com	
			1. THIS DRAWING IS THE PROPERTY OF ARCHITECT NARAYAN & ASSOCIATES AND CANNOT BE USED WITHOUT THEIR WRITTEN PERMISSION.	01.	16.08.2024	THIS DRAWING IS FOR TANDER PURPOSE ONLY	STATE BANK OF INDIA	ARMAN	JYOTI		
			2. DRAWING SHALL NOT BE SCALED. ONLY WRITTEN DIMENSION ARE TO BE FOLLOWED.				Project	Job No.	Date of Issue:		Rev. Drawn by :
			3. THIS DRAWING TO BE READ ALONG WITH OTHER RELEVANT DRAWINGS.				STATE BANK OF INDIA- L.H.O BHUBANESHWAR	CAD Reference	Scale:		
			4. ANY VARIATION BETWEEN THE DRAWING & THE SPECIFICATION SHOULD BE BROUGHT TO THE NOTICE OF THE ARCHITECTS BY THE CONTRACTS IN WRITING PRIOR TO CONSTRUCTION.				Drawing Title	Drawing No			
			5. ANY DISCREPANCIES IN THIS DRAWING, CLIENT, CONTRACTOR OR PMC TO BRING TO THE NOTICE OF THE ARCHITECT BEFORE EXECUTION.				SECOND FLOOR HVAC LAYOUT				
			6. ALL CENTRE LINE DIMENSIONS, CONTRACTOR TO STUDY THE DRAWINGS & REVERT BACK INCASE OF ANY DISCREPANCIES.				TENDER DRAWINGS				
			7. ALL DIMENSIONS ARE IN MM. DRAWING MUST BE READ IN CONJUNCTION WITH OTHER RELATED DRAWINGS. IN CASE OF ANY DISCREPANCY WITH OTHER DRAWINGS, IT NEEDED TO BE INFORMED TO THE ARCHITECT.								
			8. ALL LEVELS ARE IN METERS, FINISHED FLOOR TO BE 50-75 MM FROM THE SLAB LEVEL OR AS MENTIONED.								

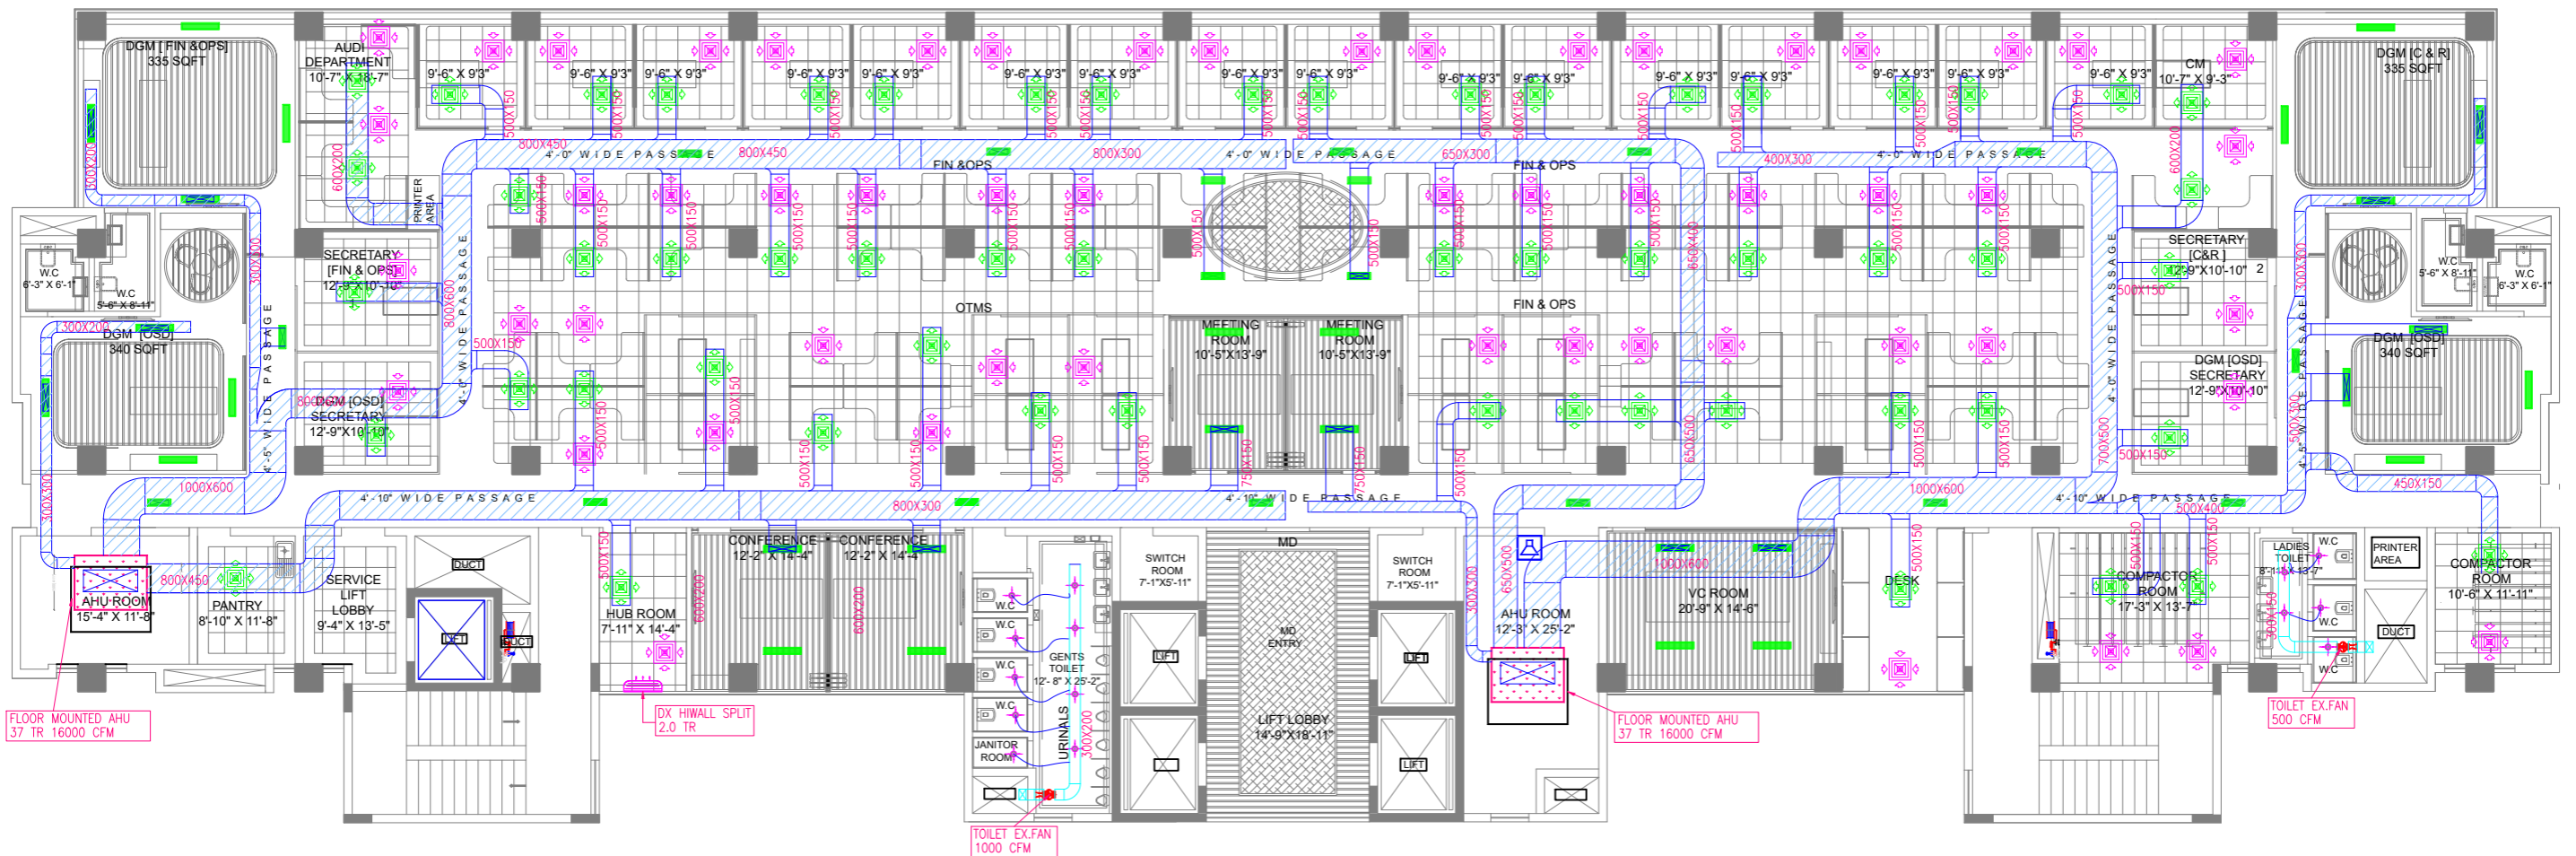


THIRD FLOOR HVAC LAYOUT

HVAC LEGEND		
SL.NO.	SYMBOL	DESCRIPTION
1		RETURN AIR DUCT WITH 19 MM THK THERMAL INSULATION
2		EXHAUST DUCT
3		SUPPLY AIR DIFFUSER
4		RETURN AIR DIFFUSER

HVAC LEGEND		
SL.NO.	SYMBOL	DESCRIPTION
5		SUPPLY & RETURN AIR GRILL
6		DISC VALVE
7		FLEXIBLE DUCT
8		HI-WALL UNIT

DATE:	08.04.2024	10	NOTE :	SR.NO.	DATE :	REMARK/COMMENTS	CLIENT:	DRAWN BY:	CHECKED BY:	Architect Narayan & Associates Pvt. Ltd. MUMBAI OFFICE, 303/304 3rd FLOOR, ANTARISKSH BUILDING MAKWANA ROAD, OFF ANDHERI KURLA RD. MAROL, ANDHERI EAST MUMBAI 400 059 Tel : 91 7208001052 , 91 7208001053 E-mail - info@architectnarayan.com
		SHEET NO.	1. THIS DRAWING IS THE PROPERTY OF ARCHITECT NARAYAN & ASSOCIATES AND CANNOT BE USED WITHOUT THEIR WRITTEN PERMISSION.	01.	08.04.2024	THIS DRAWING IS FOR TANDER PURPOSE ONLY	STATE BANK OF INDIA			
			2. DRAWING SHALL NOT BE SCALED. ONLY WRITTEN DIMENSION ARE TO BE FOLLOWED.				Project	Job No.	Date of Issue:	
			3. THIS DRAWING TO BE READ ALONG WITH OTHER RELEVANT DRAWINGS.				STATE BANK OF INDIA- L.H.O BHUBANESHWAR	CAD Reference	Rev.Drawn by :	
			4. ANY VARIATION BETWEEN THE DRAWING & THE SPECIFICATION SHOULD BE BROUGHT TO THE NOTICE OF THE ARCHITECTS BY THE CONTRACTS IN WRITING PRIOR TO CONSTRUCTION.				Drawing Title	Scale:		
			5. ANY DISCREPANCIES IN THIS DRAWING, CLIENT, CONTRACTOR OR PMC TO BRING TO THE NOTICE OF THE ARCHITECT BEFORE EXECUTION.				HVAC LAYOUT	Drawing No		
			6. ALL CENTRE LINE DIMENSIONS, CONTRACTOR TO STUDY THE DRAWINGS & REVERT BACK INCASE OF ANY DISCREPANCIES.				THIRD FLOOR			
			7. ALL DIMENSIONS ARE IN MM. DRAWING MUST BE READ IN CONJUNCTION WITH OTHER RELATED DRAWINGS. IN CASE OF ANY DISCREPANCY WITH OTHER DRAWINGS, IT NEEDED TO BE INFORMED TO THE ARCHITECT.							
			8. ALL LEVELS ARE IN METERS, FINISHED FLOOR TO BE 50-75 MM FROM THE SLAB LEVEL OR AS MENTIONED.							

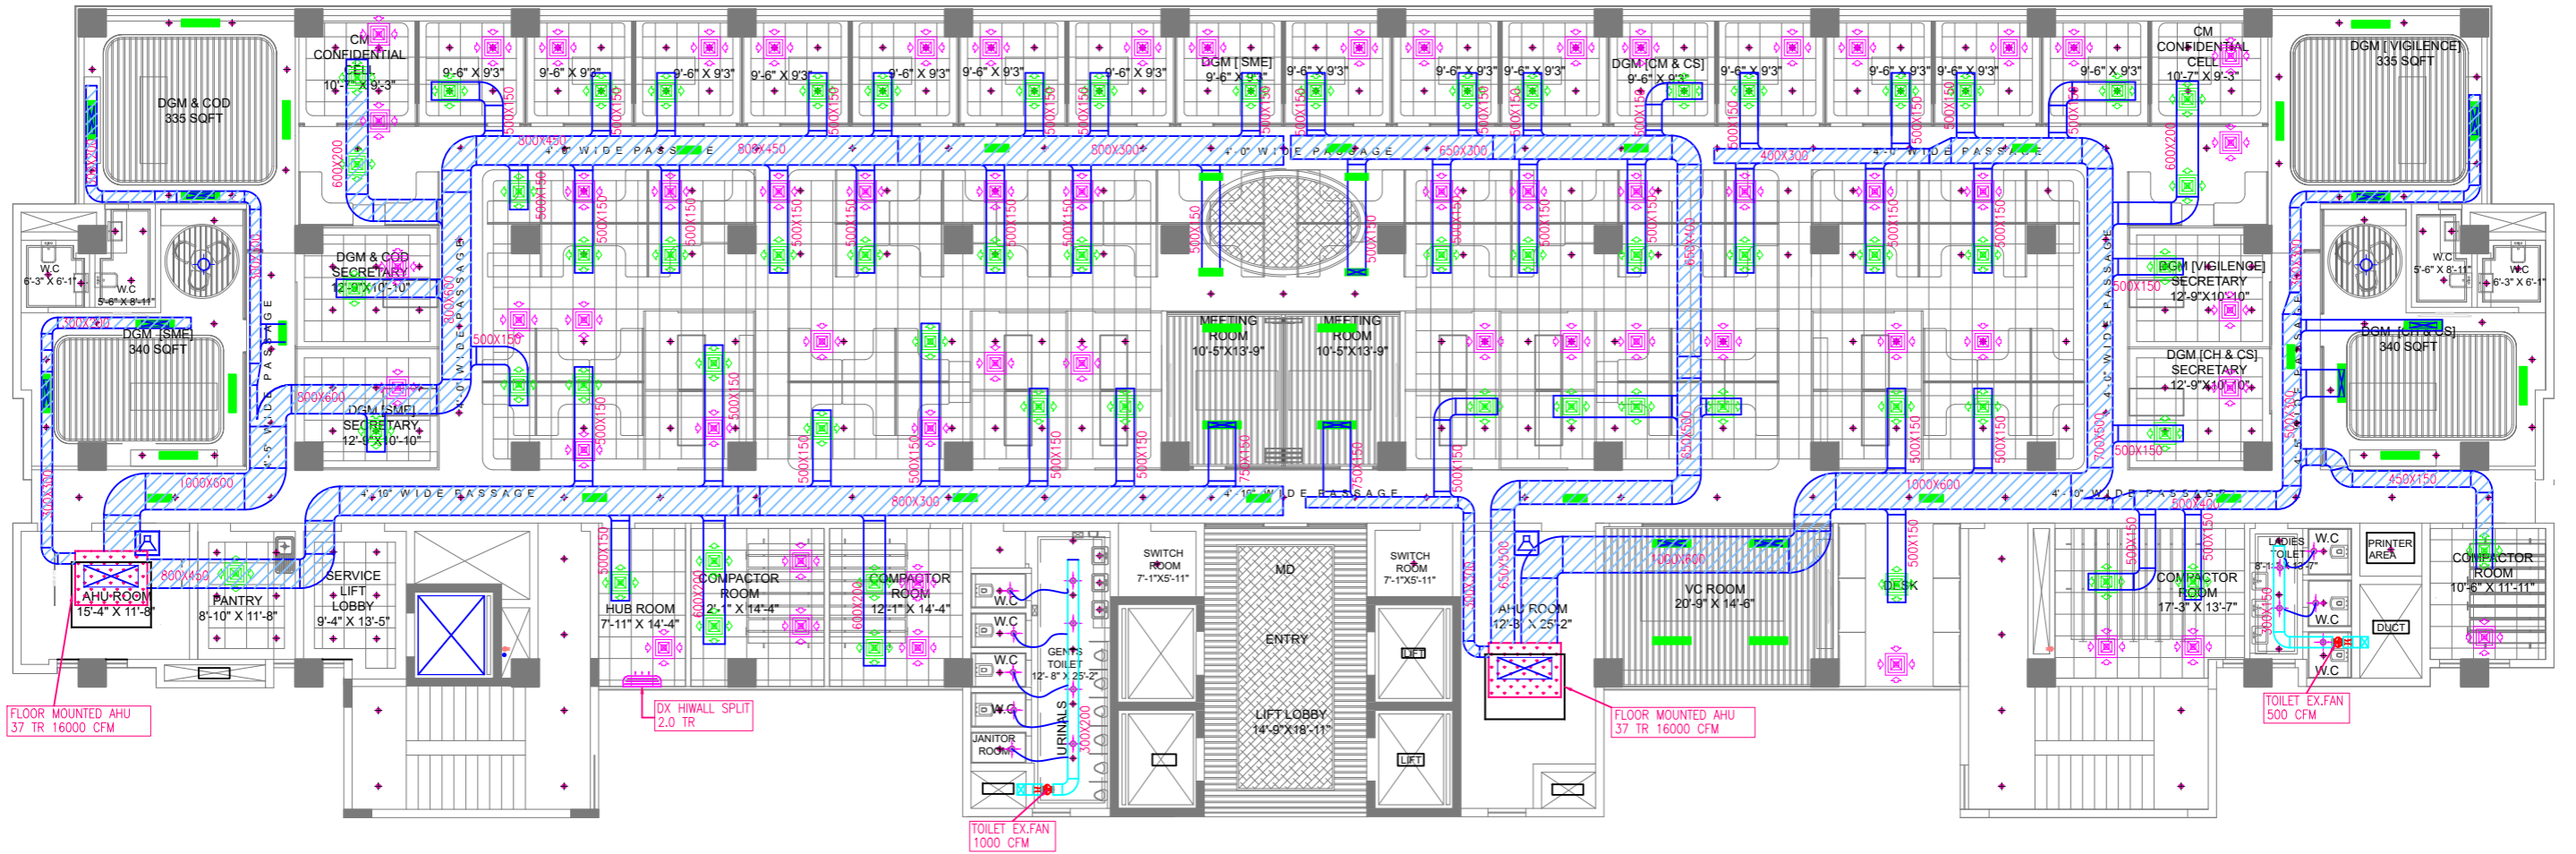

FOURTH FLOOR HVAC LAYOUT

HVAC LEGEND		
SL.NO.	SYMBOL	DESCRIPTION
1		RETURN AIR DUCT WITH 19 MM THK THERMAL INSULATION
2		EXHAUST DUCT
3		SUPPLY AIR DIFFUSER
4		RETURN AIR DIFFUSER

HVAC LEGEND		
SL.NO.	SYMBOL	DESCRIPTION
5		SUPPLY & RETURN AIR GRILL
6		DISC VALVE
7		FLEXIBLE DUCT
8		HI-WALL UNIT

DATE: 16.08.2024 15 SHEET NO.

NOTE :
 1. THIS DRAWING IS THE PROPERTY OF ARCHITECT NARAYAN & ASSOCIATES AND CANNOT BE USED WITHOUT THEIR WRITTEN PERMISSION.
 2. DRAWING SHALL NOT BE SCALED. ONLY WRITTEN DIMENSION ARE TO BE FOLLOWED.
 3. THIS DRAWING TO BE READ ALONG WITH OTHER RELEVANT DRAWINGS.
 4. ANY VARIATION BETWEEN THE DRAWING & THE SPECIFICATION SHOULD BE BROUGHT TO THE NOTICE OF THE ARCHITECTS BY THE CONTRACTS IN WRITING PRIOR TO CONSTRUCTION.
 5. ANY DISCREPANCIES IN THIS DRAWING, CLIENT, CONTRACTOR OR PMC TO BRING TO THE NOTICE OF THE ARCHITECT BEFORE EXECUTION.


6. ALL CENTRE LINE DIMENSIONS, CONTRACTOR TO STUDY THE DRAWINGS & REVERT BACK INCASE OF ANY DISCREPANCIES.
 7. ALL DIMENSIONS ARE IN MM. DRAWING MUST BE READ IN CONJUNCTION WITH OTHER RELATED DRAWINGS. IN CASE OF ANY DISCREPANCY WITH OTHER DRAWINGS, IT NEEDED TO BE INFORMED TO THE ARCHITECT.
 8. ALL LEVELS ARE IN METERS, FINISHED FLOOR TO BE 50-75 MM FROM THE SLAB LEVEL OR AS MENTIONED.

SR.NO.	DATE :	REMARK/COMMENTS
01.	16.08.2024	THIS DRAWING IS FOR TANDER PURPOSE ONLY

CLIENT: STATE BANK OF INDIA
 Project: STATE BANK OF INDIA- L.H.O BHUBANESHWAR
 Drawing Title: FOURTH FLOOR HVAC LAYOUT
 TENDER DRAWINGS

DRAWN BY: ARMAN
 CHECKED BY: JYOTI
 Job No. Date of Issue: Rev.Drawn by :
 CAD Reference Scale:
 Drawing No. SBI/BHU/LA-15

Architect Narayan & Associates Pvt. Ltd.
 MUMBAI OFFICE:
 303/304 3rd FLOOR, ANTARISKSH BUILDING MAKWANA ROAD, OFF ANDHERI KURLA RD. MAROL, ANDHERI EAST MUMBAI 400 059
 Tel : 91 7208001052 , 91 7208001053
 E-mail - info@architectnarayan.com

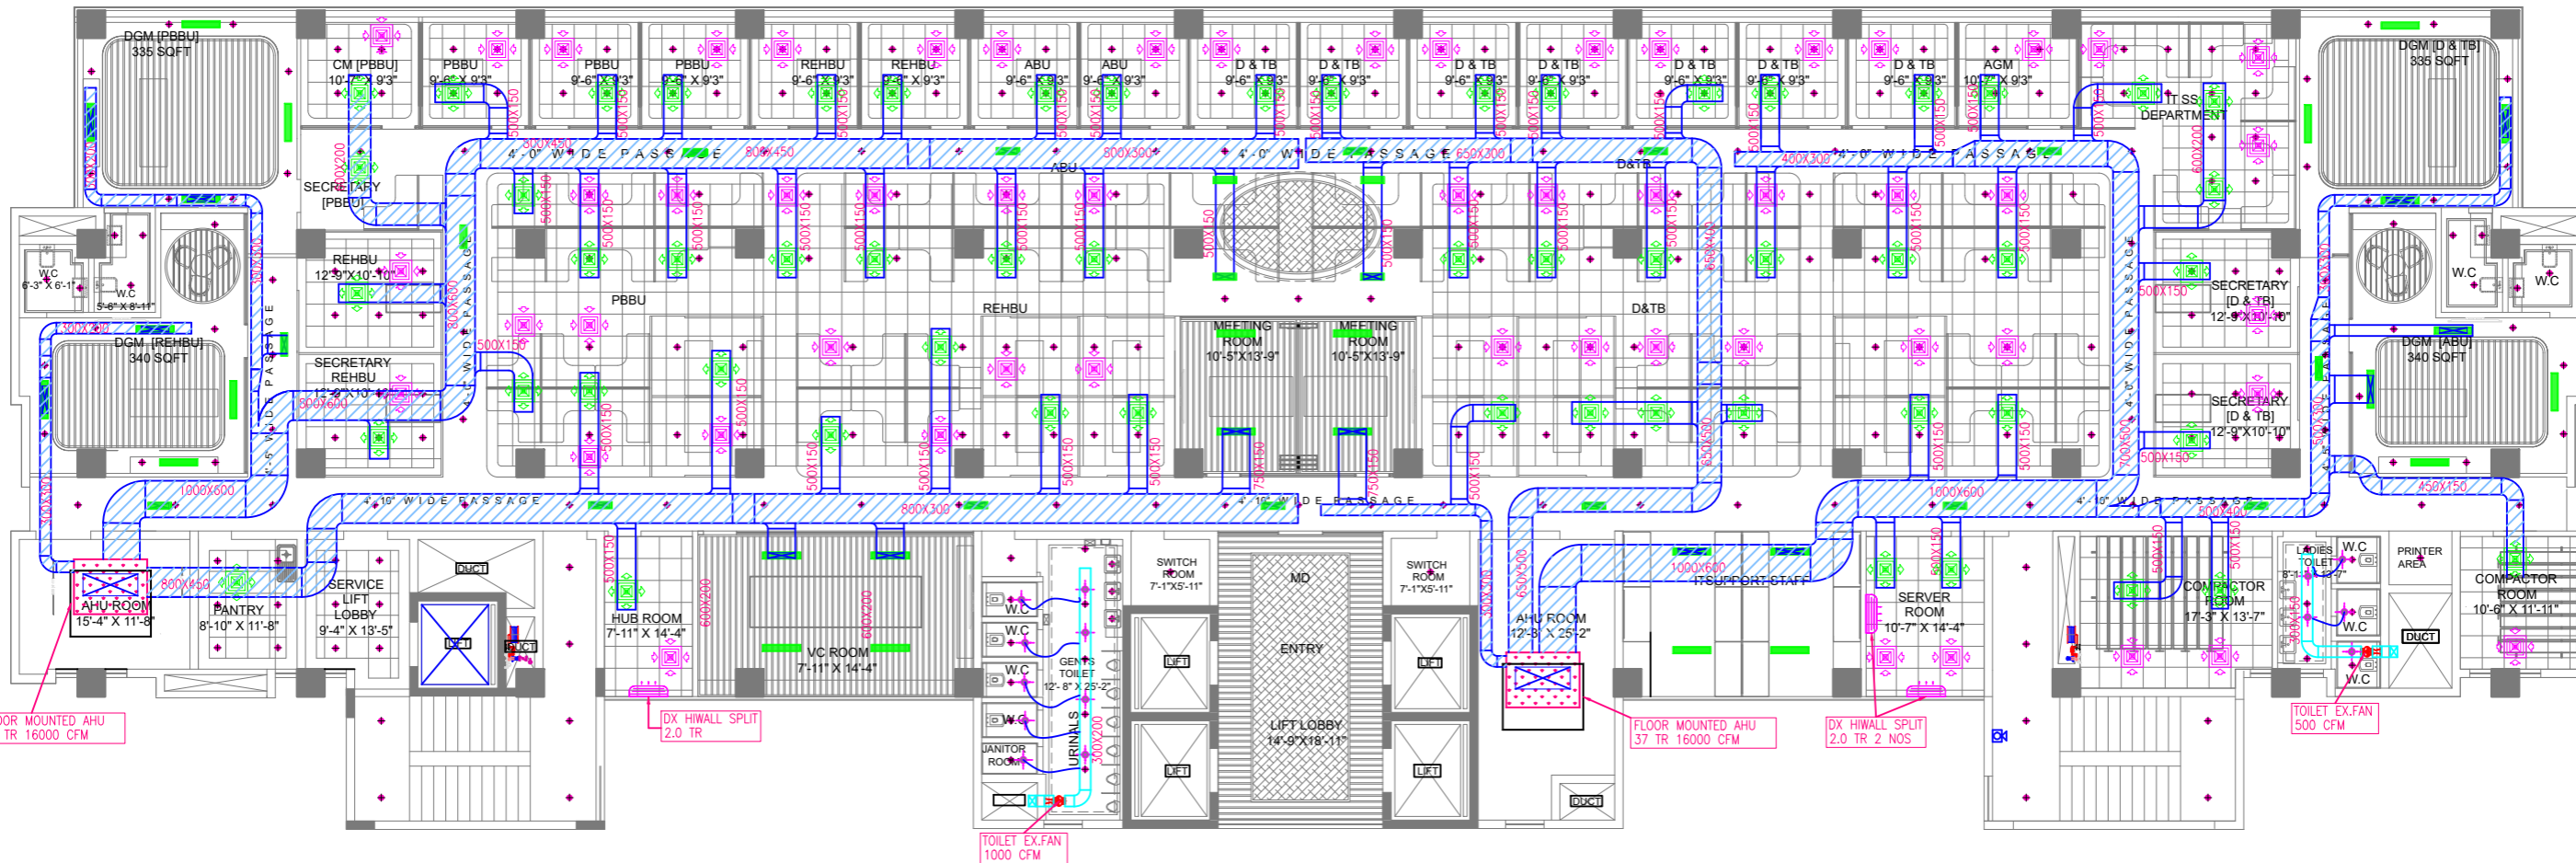

FIFTH FLOOR HVAC LAYOUT

HVAC LEGEND		
SL.NO.	SYMBOL	DESCRIPTION
1		RETURN AIR DUCT WITH 19 MM THK THERMAL INSULATION
2		EXHAUST DUCT
3		SUPPLY AIR DIFFUSER
4		RETURN AIR DIFFUSER

HVAC LEGEND		
SL.NO.	SYMBOL	DESCRIPTION
5		SUPPLY & RETURN AIR GRILL
6		DISC VALVE
7		FLEXIBLE DUCT
8		HI-WALL UNIT

DATE: 16.08.2024 20

NOTE :

- THIS DRAWING IS THE PROPERTY OF ARCHITECT NARAYAN & ASSOCIATES AND CANNOT BE USED WITHOUT THEIR WRITTEN PERMISSION.
- DRAWING SHALL NOT BE SCALED. ONLY WRITTEN DIMENSION ARE TO BE FOLLOWED.
- THIS DRAWING TO BE READ ALONG WITH OTHER RELEVANT DRAWINGS.
- ANY VARIATION BETWEEN THE DRAWING & THE SPECIFICATION SHOULD BE BROUGHT TO THE NOTICE OF THE ARCHITECTS BY THE CONTRACTS IN WRITING PRIOR TO CONSTRUCTION.
- ANY DISCREPANCIES IN THIS DRAWING, CLIENT, CONTRACTOR OR PMC TO BRING TO THE NOTICE OF THE ARCHITECT BEFORE EXECUTION.

- ALL CENTRE LINE DIMENSIONS, CONTRACTOR TO STUDY THE DRAWINGS & REVERT BACK INCASE OF ANY DISCREPANCIES.
- ALL DIMENSIONS ARE IN MM. DRAWING MUST BE READ IN CONJUNCTION WITH OTHER RELATED DRAWINGS. IN CASE OF ANY DISCREPANCY WITH OTHER DRAWINGS, IT NEEDED TO BE INFORMED TO THE ARCHITECT.
- ALL LEVELS ARE IN METERS, FINISHED FLOOR TO BE 50-75 MM FROM THE SLAB LEVEL OR AS MENTIONED.

SR.NO.	DATE :	REMARK/COMMENTS
01.	16.08.2024	THIS DRAWING IS FOR TANDER PURPOSE ONLY

CLIENT: STATE BANK OF INDIA

Project: STATE BANK OF INDIA- L.H.O BHUBANESHWAR

Drawing Title: FIFTH FLOOR HVAC LAYOUT

TENDER DRAWINGS

DRAWN BY: ARMAN

CHECKED BY: JYOTI

Job No. Date of Issue: Rev.Drawn by :

CAD Reference Scale:

Drawing No: SBI/BHU/LA-20

Architect Narayan & Associates Pvt. Ltd.

MUMBAI OFFICE:
303/304 3rd FLOOR, ANTARISKSH BUILDING
MAKWANA ROAD, OFF ANDHERI KURLA RD.
MAROL, ANDHERI EAST MUMBAI 400 059

Tel : 91 7208001052 , 91 7208001053
E-mail - info@architectnarayan.com